

FACILITY CODE: 671-0178

215 COLLEGE CIRCLE, BUCHANAN, GA 30113

HARALSON COUNTY SCHOOLS

NO.	DRAWING NAME	DATE
GENERAL		
GD 0	COVER	01/04/2023
ARCHITECTURAL		
AT 0	OVERALL PLAN, FLOOR PLAN	01/04/2023
MECHANICAL		
MT 0	HVAC LEGEND, SCHEDULES, AND DETAILS	01/04/2023
MT 1	HVAC FLOOR PLAN	01/04/2023
ELECTRICAL		
ED 1	SYMBOL LEGEND, GENERAL NOTES, PANELBOARD SCHEDULE, & RISER DIAGRAM	01/04/2023
E01	FLOOR PLANS - ELECTRICAL	01/04/2023

BXA
Breaux & Associates
ARCHITECTS

5955 Shiloh Road East, Suite 200
Alpharetta, Georgia 30005 | (678) 585-4500

[illegible]

BUCHANAN ELEMENTARY SCHOOL
GYMNASIUM MODIFICATION
215 COLLEGE CIRCLE, BUCHANAN, GA 30113
(FACILITY CODE: 671-0178)

HARALSON COUNTY SCHOOLS

DISCIPLINE REFERENCE

BUILDING NUMBER
 (1, 2 OR 3 IS REQUIRED IF NO NUMBER PRESENT
 SHEET APPLIES TO CAMPUS OR ALL BUILDINGS)

GENERAL SHEET ORGANIZATION

SUITE - ROOM NUMBERING

LEVEL REFERENCE

SUITE NUMBER

ROOM NUMBER

DOOR LOCATION REFERENCE (BASED ON SUITE/ROOM NUMBERING - SEE ABOVE)

DOOR NUMBER

OWNER
HARALSON COUNTY SCHOOLS
239 ROBERTSON AVENUE
TALLAPOOSA, GA 30176
(770) 574-2500
CONTACT: DR. JERRY BELL

ARCHITECT
BREAUX & ASSOCIATES
ARCHITECTS
5955 SHILOH ROAD EAST,
SUITE 200
ALPHARETTA, GEORGIA 30005
(678) 585-4508
ConstructionAdmin@BXArch.com

ENGINEERS
ELECTRICAL
MATHIS CONSULTING ENGINEERS
244 ODELL RD., SUITE E
GRiffin, GEORGIA 30224
(404) 237-8632

MECHANICAL
BAA MECHANICAL ENGINEERS,
INC.
500 BISHOP ST., SUITE E-2
ATLANTA, GEORGIA 30318
(404) 535-1020


2018 IBC with 2020 & 2022 Georgia Amendments
2018 IPC with 2020 & 2022 Georgia Amendments
2018 IMC with 2020 Georgia Amendments
2018 IFGC with 2020 & 2022 Georgia Amendments
2020 National Electric Code
2018 NFPA 101 Life Safety Code
2018 International Fire Code
Georgia Accessibility Code
2010 ADA Standards for Accessible Design
2004 ADAAG
2015 International Energy Conservation Code (IECC) with 2020
& 2022 Supplements and Amendments

OCCUPANCY CLASSIFICATION: EXISTING EDUCATIONAL AND EXISTING ASSEMBLY
CONSTRUCTION TYPE: EXISTING
SPRINKLERED: N/A
OVERALL AREA: 9120 SF
NO. OF STORIES: TWO (NOT AFFECTED BY PROPOSED SCOPE)

PROJECT SCOPE SHALL INCLUDE THE REPLACEMENT OF EXISTING HVAC SYSTEM WITH NEW HVAC SYSTEM FOR THE GYMNASIUM (BUILDING 2030)

[illegible]


DATE	01/04/2023
PROJECT NO.	22131
G0.0	

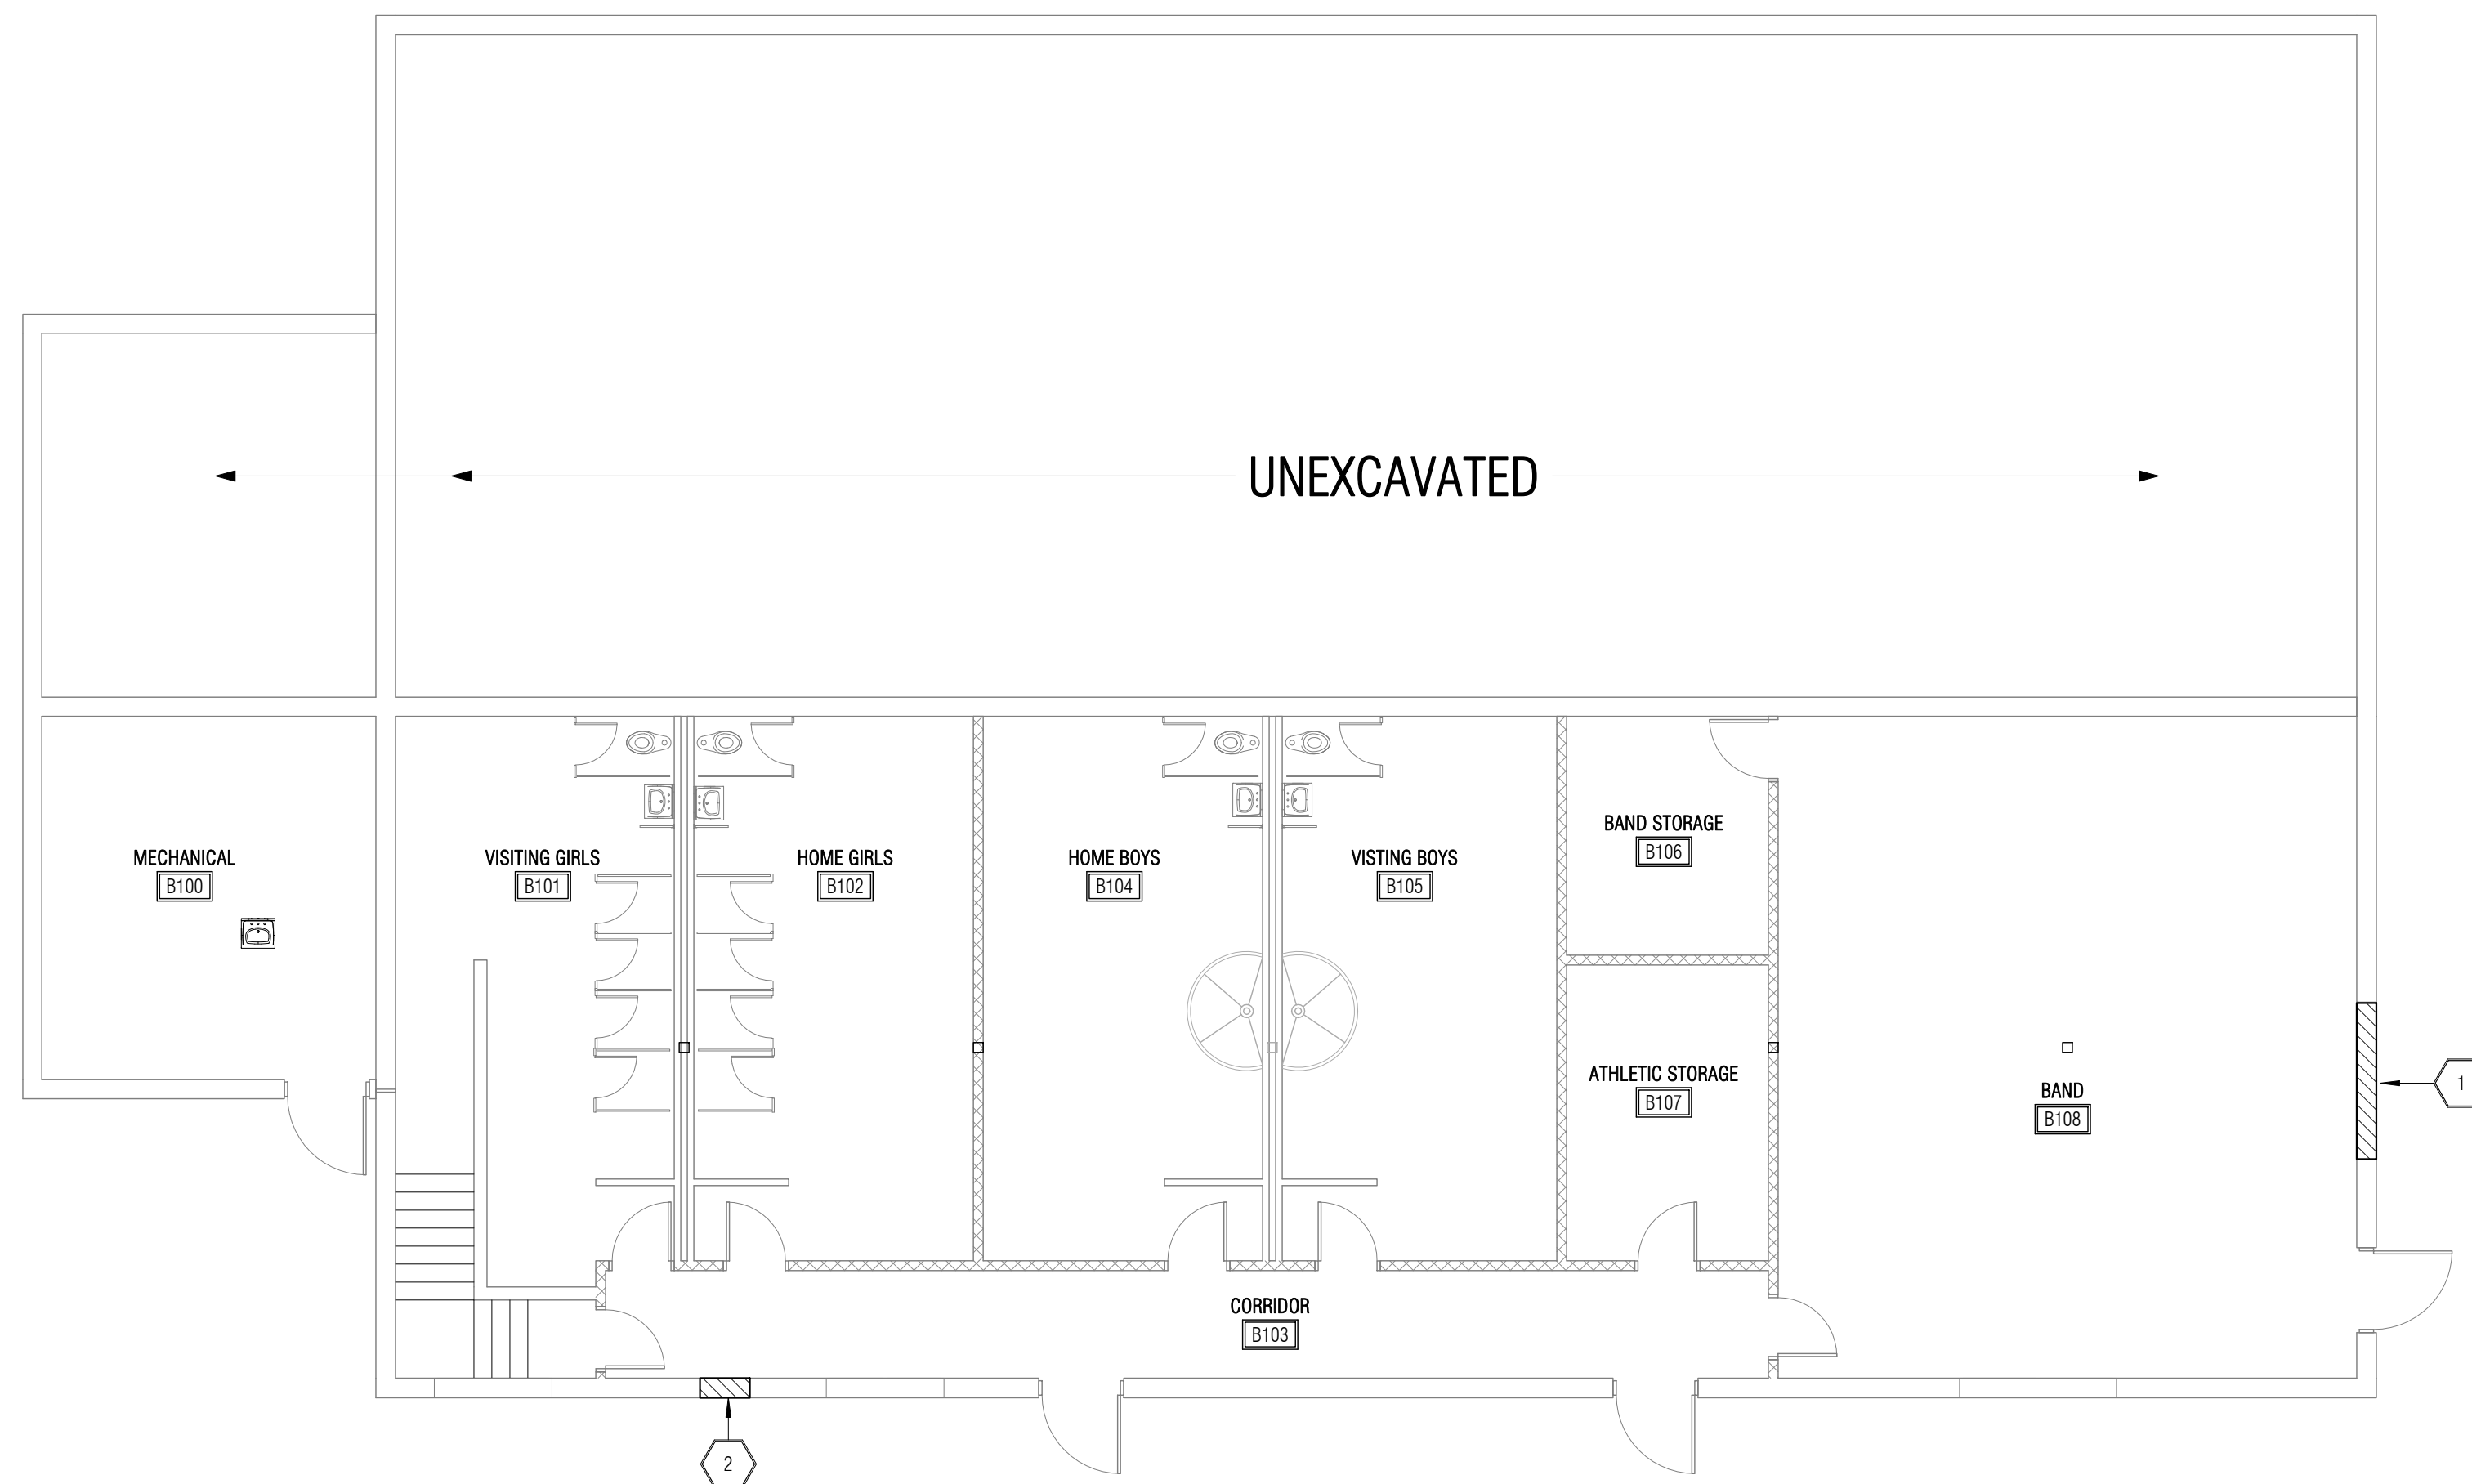

2	FLOOR PLAN - LEVEL 1
A1.0	SCALE: 1/8" = 1'-0"


REFER TO MECHANICAL FOR ADDITION WORKS ON ROOF AND PLAN

NO	DRAWING NOTES
1	DEMOLISH EXISTING WINDOW. INFILL OPENING AND FINISH TO MATCH EXISTING.
2	REMOVE EXISTING WALL EXHAUST FAN. PATCH AND FINISH TO MATCH EXISTING

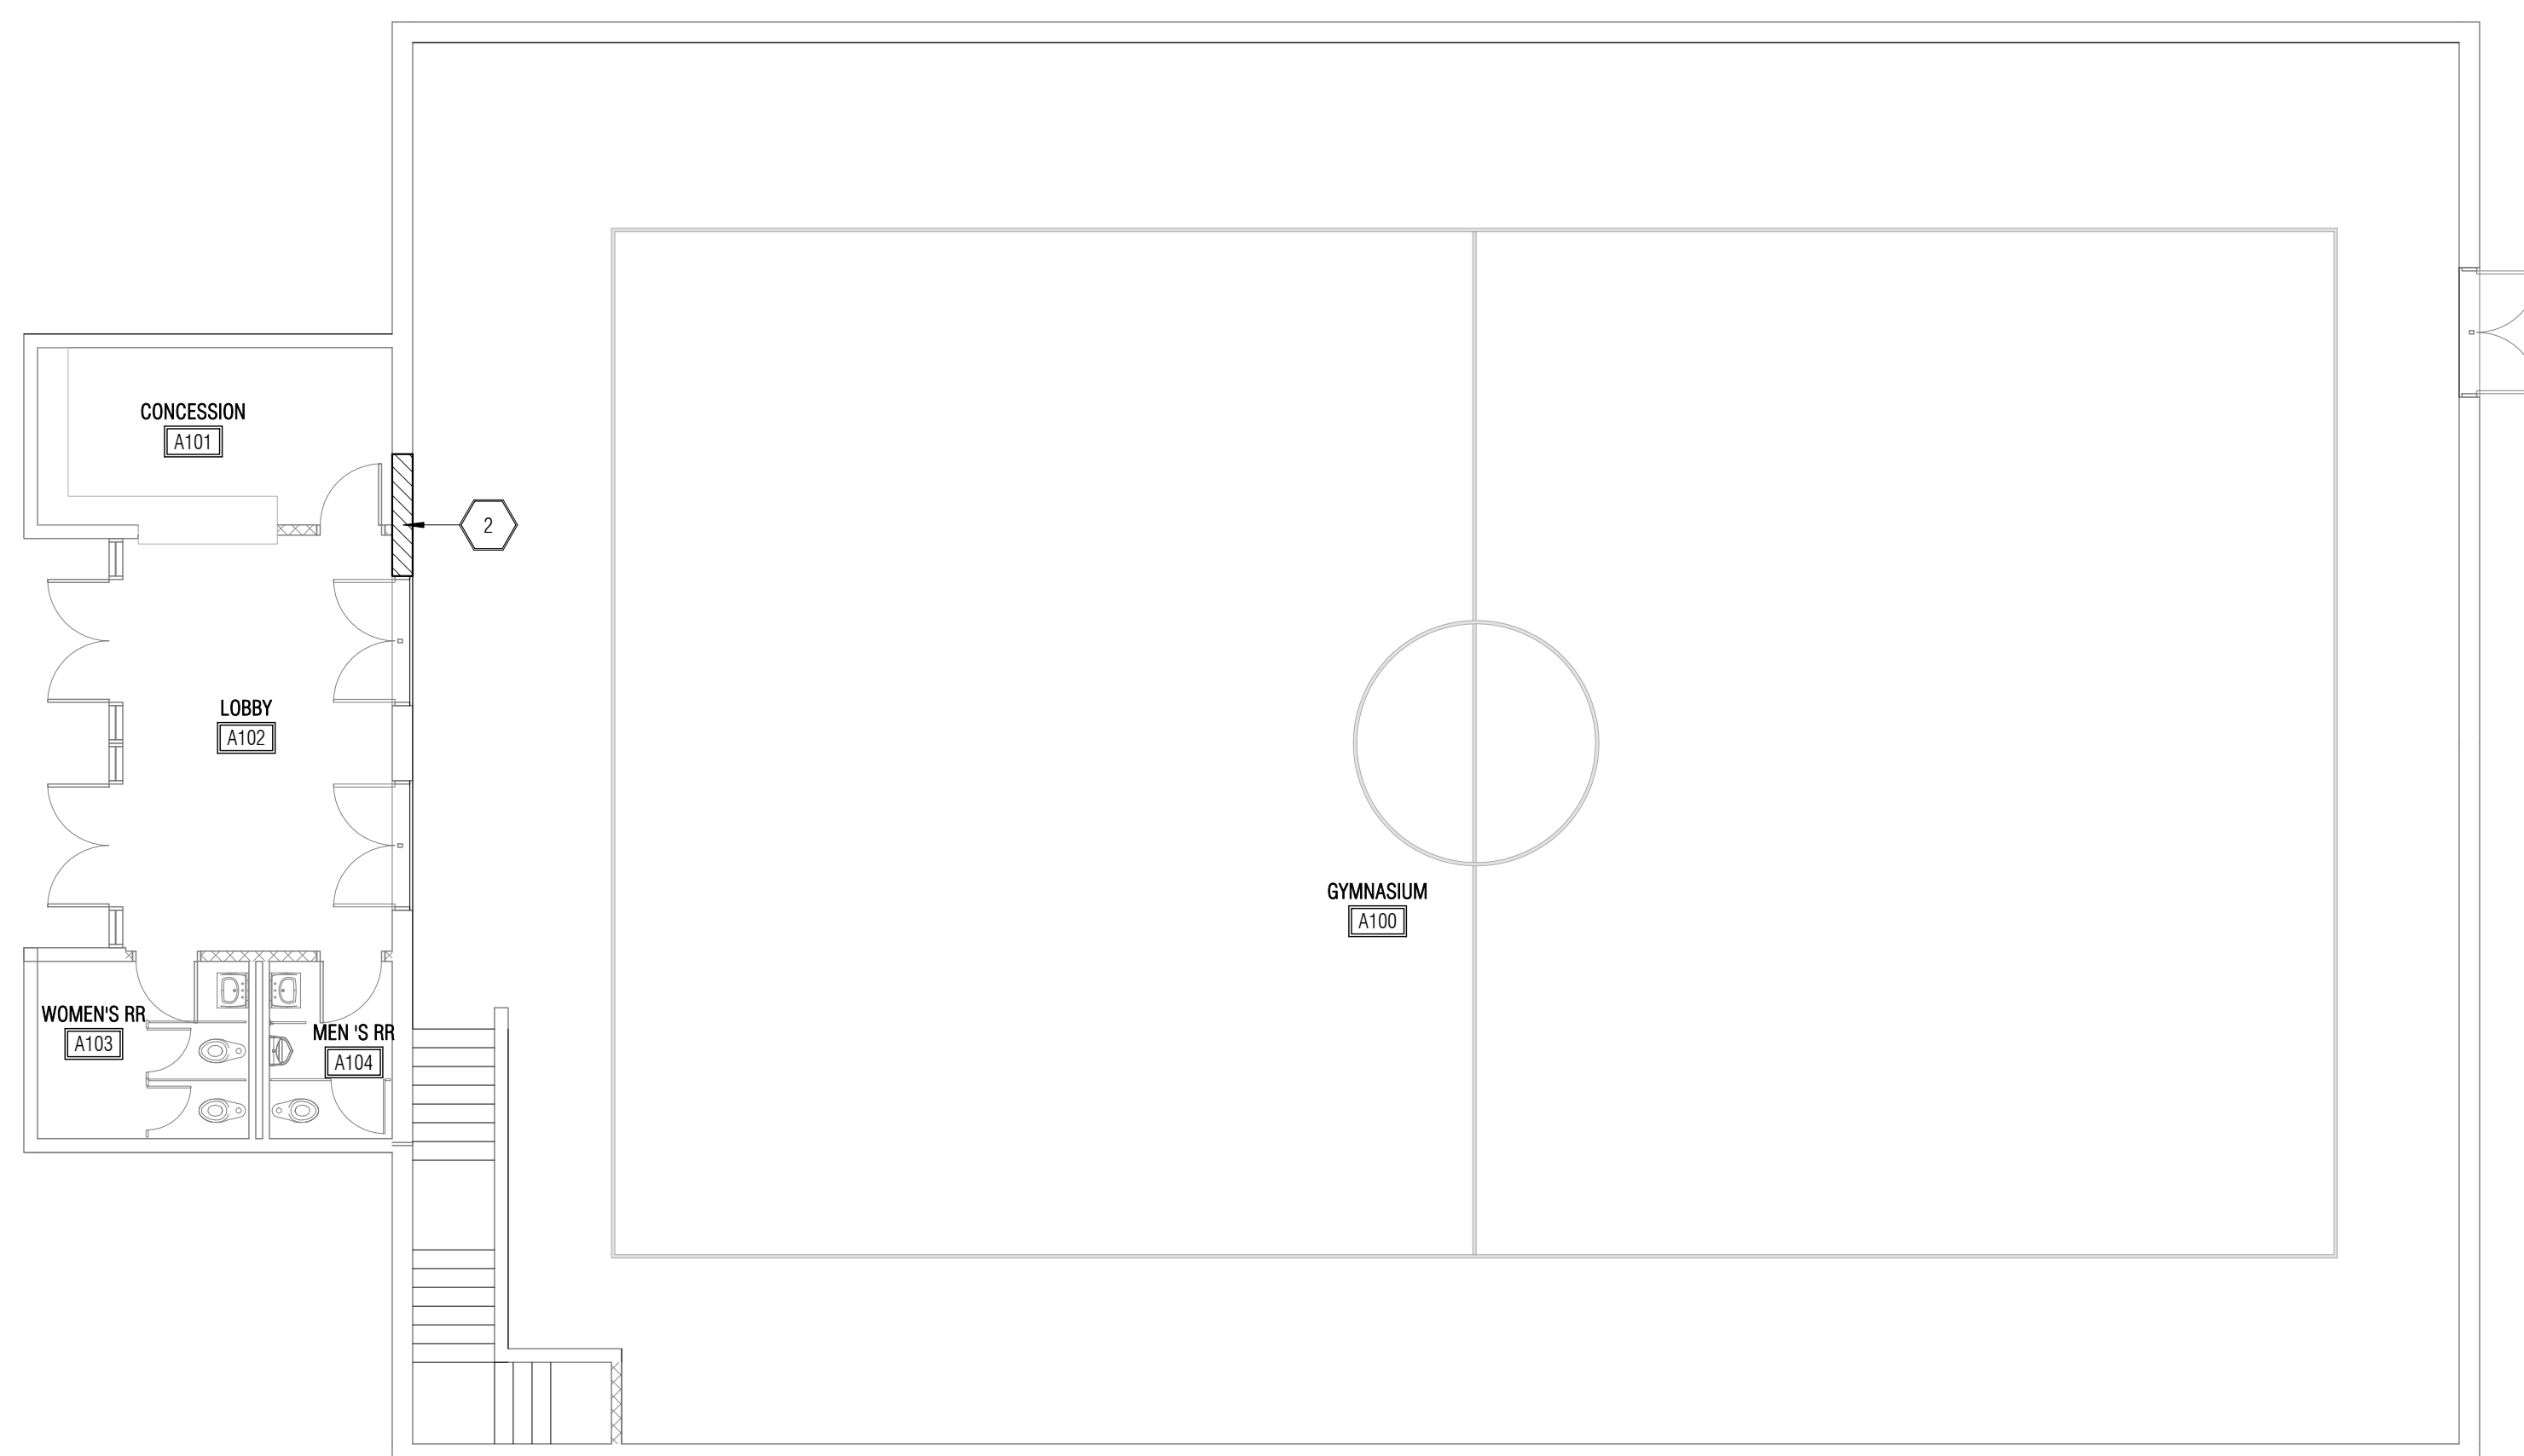

3	FLOOR PLAN - LEVEL 2
A1.0	SCALE: 1/8" = 1'-0"

REFER TO MECHANICAL FOR ADDTION WORKS ON ROOF AND REFLETED CEILING PLAN

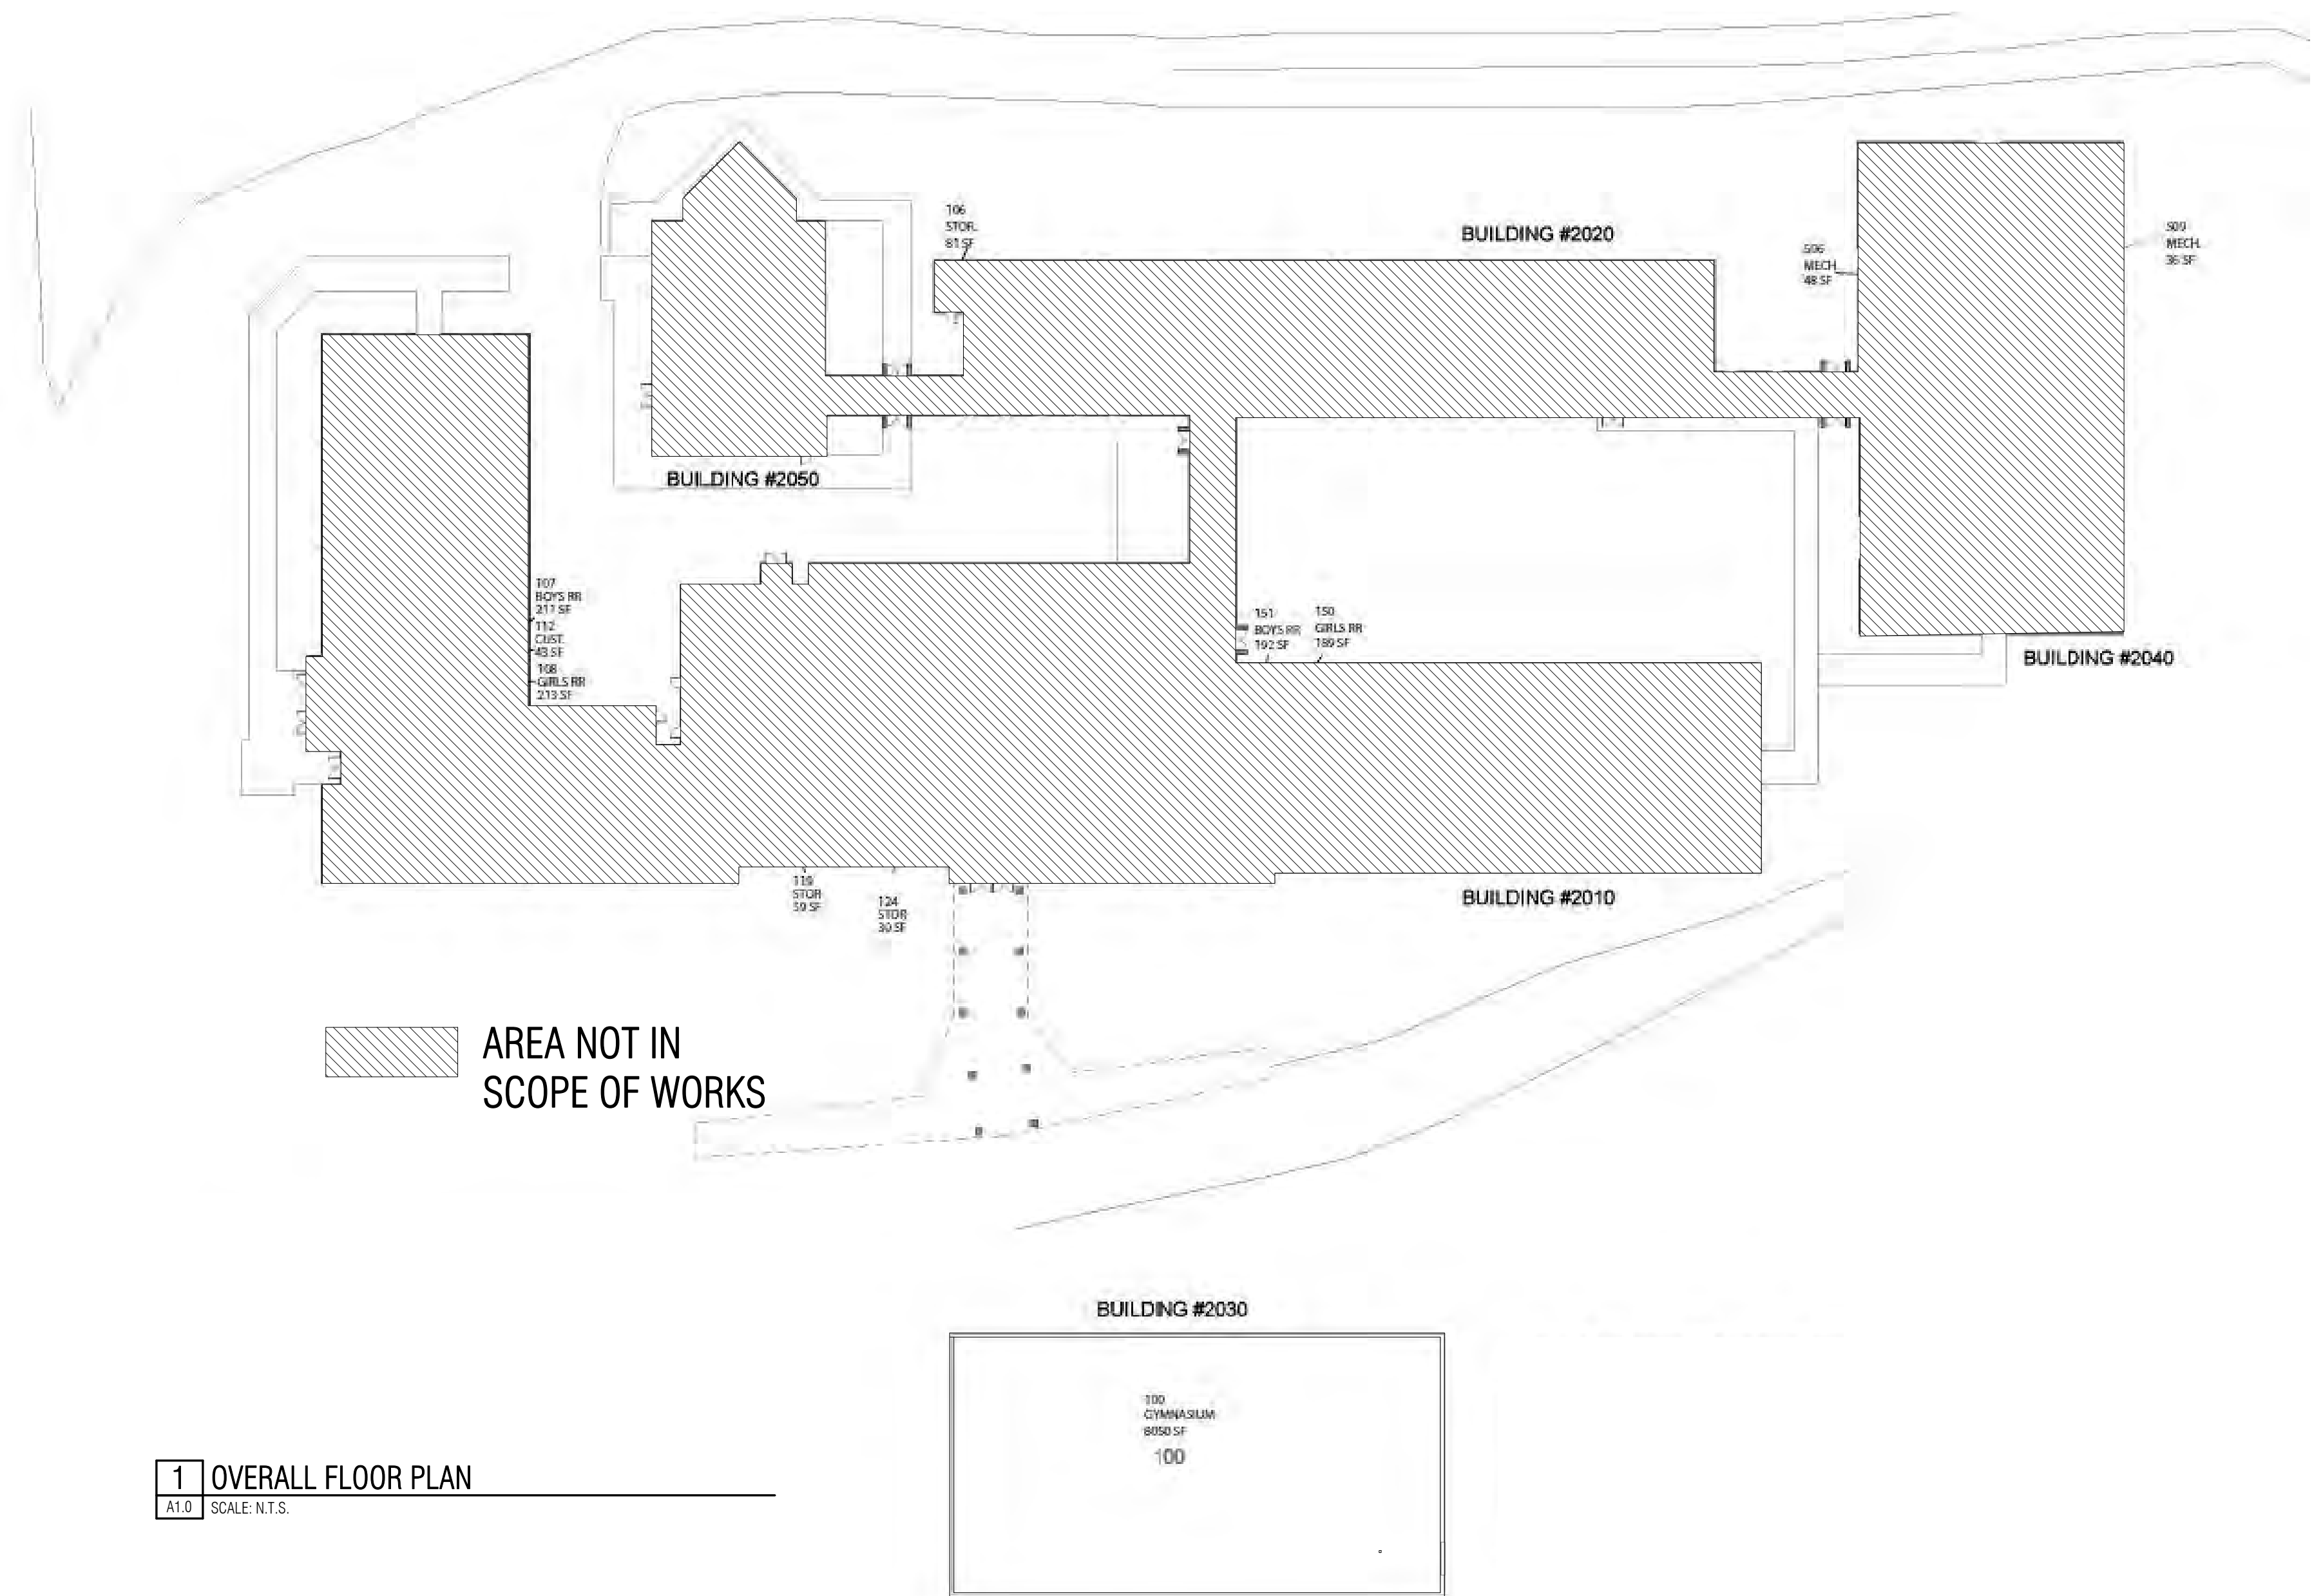

1	OVERALL FLOOR PLAN
A1.0	SCALE: N.T.S.

[illegible]


BUCHANAN ELEMENTARY SCHOOL
GYMNASIUM MODIFICATION
215 COLLEGE CIRCLE, BUCHANAN, GA 30113
(FACILITY CODE: 671-0178)

	4/2023		HARALSON COUNTY SCHOOLS
	22131		
			50960 SF (EXISTING AREA) + 0 SF (NEW AREA) = 50960 SF (TOTAL AREA); 348 F.T.E. (EXISTING) + 0 F.T.E. (NEW) = 348 F.T.E. (TOTAL); 36 I.U. (EXISTING) + 0 I.U. (NEW) = 36 I.U. (TOTAL)

OVERALL PLAN, FLOOR PLAN

DATE	01/04/2023
PROJECT NO.	22131

A1.0

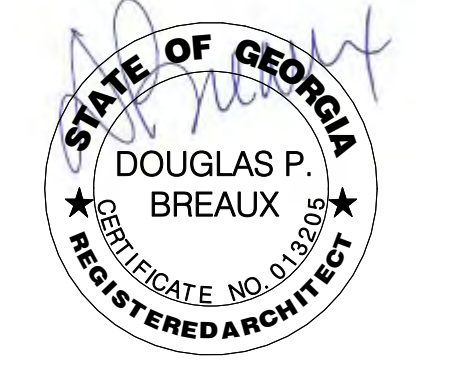

1/04/2023

NEW PANELBOARD MDP SCHEDULE																			
VOLTAGE: 120/208V, 3 PH, 4 W				MAINS: 300A MAIN BREAKER				MOUNTING SURFACE				REMARKS:							
BUS SIZE: 400A				TOTAL LOAD: (OVERSEEN LOAD) 5750 KVA				FAULT DUTY: 25,000 A/C				NEMA 3R							
NO	SERVICES	NOT	LOAD (KVA)				BKR	PHASE	LOAD (KVA)				NOT	SERVICES	NO				
			LTG	NCHT	HTN	A/C			HTG	HTN	NCHT	A/C							
1	PMU-2					48.4		T5	A	1	20			Ø2	RECEPTACLE	1			
2	PMU-2								B	1	20				SPARE	2			
3	PMU-2								C	1	20				SPARE	3			
4	PMU-2									1	20				SPARE	4			
5	SPACE														SPACE	5			
6	SPACE														SPACE	6			
7	SPACE														SPACE	7			
8	PMU-1					62		T5	A	3	30				SPACE	8			
9	PMU-1								B	3	30				SPACE	9			
10	PMU-1								C	3	30				SPACE	10			
11	PMU-1									3	30				SPACE	11			
12	SPACE														SPACE	12			
13	SPACE														SPACE	13			
14	SPACE														SPACE	14			
15	SPACE														SPACE	15			
16	SPACE														SPACE	16			
17	SPACE														SPACE	17			
18	SPACE														SPACE	18			
19	SPACE														SPACE	19			
20	SPACE														SPACE	20			
21	SPACE														SPACE	21			
22	SPACE														SPACE	22			
23	SPACE														SPACE	23			
LOAD SUMMARY								LIGHTING: ØØ KVA								A/C: 516 KVA			
								RECEPTACLE: Ø2 KVA								HEATING: ØØ KVA			
								MOTOR: ØØ KVA								MISC: ØØ KVA			


NOTES:

A. CONTRACTOR PROPOSING TO UNDERTAKE WORK UNDER THIS DIVISION SHALL VISIT THE SITE OF THE WORK AND FULLY INFORM THEMSELVES OF ALL CONDITIONS THAT EFFECT THE WORK OR COULD AFFECT THE WORK. CONTRACTOR SHALL BE RESPONSIBLE FOR ALL ASSESSMENTS RELATED TO THE SITE CONDITIONS, PRIORS TO SUBMITTING HIS PROPOSAL FOR WORK.

B. CONSIDERATION WILL NOT BE GRANTED FOR ANY ALLEGED "MISUNDERSTANDINGS" OF THE AMOUNT OF WORK TO BE PERFORMED. TENDER OF PROPOSORIAL SHALL CONVEY FULL AGREEMENT TO THE AMOUNT AND SCOPE OF THE WORK. CONTRACTOR SHALL BE RESPONSIBLE FOR ANY DISCREPANCIES OR OMISSIONS IN THE CONTRACT DOCUMENTS OR BE, IN DOUBT AS TO THE INTENT THEREOF, SHALL IMMEDIATELY OBTAIN CLARIFICATION FROM THE ENGINEER AND/OR OWNER FOR REPRESENTATION AT THE SITE.

C. CONTRACTOR SHALL REFER TO MECHANICAL DRAWINGS FOR ALL EXISTING TO BE REMOVED HVAC EQUIPMENT. ALL ASSOCIATED ELECTRICAL SHALL BE REMOVED INCLUDING CONTROL. ASSOCIATED BREAKERS SHALL BE IN THE "OFF" POSITION AND LABELED "SPARE". THIS DOES NOT APPLY TO

SYMBOL LEGEND			
NOTING: HEIGHT IS FROM FINISHED FLOOR TO CENTERLINE OF DEVICE OR OUTLET HEIGHT MAY VARY TO CONFORM WITH BUILDING OR CONSTRUCTION			
SYMBOL	DESCRIPTION	POINTING HEIGHT	
○	DOWNLIGHT		
○	LIGHT FIXTURE - WALL MOUNTED	AS NOTED	
○	2' X 4' LIGHT FIXTURE		
■	2' X 4' LIGHT FIXTURE ON EMERGENCY CIRCUIT		
□	1' X 4' LIGHT FIXTURE		
■	1' X 4' LIGHT FIXTURE ON EMERGENCY CIRCUIT		
⊙	EXIT SIGN - CEILING MOUNTED DARKENED SECTION(S) OF SYMBOLS INDICATE FACES OF FIXTURE		
⊙	EXIT SIGN - WALL MOUNTED DARKENED SECTION(S) OF SYMBOLS INDICATE FACES OF FIXTURE		
⊙	EXIT SIGN - CEILING MOUNTED DARKENED SECTION(S) OF SYMBOLS INDICATE FACES OF FIXTURE		
⊙	EXIT SIGN - WALL MOUNTED DARKENED SECTION(S) OF SYMBOLS INDICATE FACES OF FIXTURE		
S ³	KEY OPERATED THREE-WAY SWITCH	48"	
S	8-P.S.T. LIGHT SWITCH	48"	
⊙	WALL MOUNTED SENSOR SWITCH DUAL TECHNOLOGY (HUBBELL - LHM18-B BASIS OF DESIGN)		
⊙	LOW VOLTAGE DUAL TECHNOLOGY 360 DEGREE CEILING MOUNTED OCCUPANCY SENSOR (HUBBELL - 0PM-UT-2000 BASIS OF DESIGN)	---	
⊙	LOW VOLTAGE DUAL TECHNOLOGY 360 DEGREE SURFACE MOUNTED OCCUPANCY SENSOR FOR AREAS WHERE MOUNTING HEIGHT IS 5'-0" OR MORE (HUBBELL - USP-SM-SV SENSOR USP-LM60-40 LENS BASIS OF DESIGN)	---	
⊙	POWER FRAC INSTALLED ABOVE CEILING (HUBBELL - VPMF-B BASIS OF DESIGN)		
D	240 VOLT SLIDE DIFFER WITH ON/OFF SWITCH (INCLUDE POWER PAK IF LONG EXPOSED LENGTH OF EXPOSED)	48"	
S	THREE-WAY LIGHT SWITCH	48"	
S	FOUR-WAY LIGHT SWITCH	48"	
S	KEY OPERATED LIGHT SWITCH	48"	
⊙	SINGLE RECEPTACLE OUTLET (TAMPER PROOF)	18"	
⊙	DUPLEX RECEPTACLE OUTLET (TAMPER PROOF)	18"	
⊙	DUPLEX RECEPTACLE OUTLET WITH 2 USB PORTS (TAMPER PROOF)	18"	
⊙	QUAD RECEPTACLE OUTLET (TAMPER PROOF)	18"	
⊙	DUPLEX RECEPTACLE MOUNTED 6" ABOVE BACKSPASH (TAMPER PROOF)	---	
⊙	JUNCTION BOX W/COVERPLATE - ABOVE CEILING	---	
⊙	JUNCTION BOX W/COVERPLATE - WALL MOUNTED	---	
⊙	IC FLOOR SLAB TO ACCOMMODATE DATA CABLES	---	
⊙	SPECIAL OUTLET (AS NOTED)	---	
⊙	PANELBOARD 480V	---	
⊙	PANELBOARD 240V	---	
⊙	DISCONNECT SWITCH - HORSEPOWER RATED	---	
⊙	MOTOR - FRACTIONAL HORSEPOWER	---	
⊙	MOTOR - NUMERAL INDICATES HORSEPOWER	---	
⊙	TELEPHONE OUTLET WITH IC STUBBED INTO ACCESSIBLE PLENUM	48"	
⊙	DATA OUTLET WITH IC STUBBED INTO ACCESSIBLE PLENUM	18"	
⊙	MICROPHONE OUTLET	18"	
⊙	AUDIO VISUAL OUTLET 4"x4" JUNCTION BOX WITH 1/2" IC STUBBED INTO ACCESSIBLE PLENUM	AS NOTED	
⊙	FIRE ALARM PULL STATION	---	
⊙	FIRE ALARM STROBE (CEILING MOUNTED (WHITE)	---	
⊙	CEILING MOUNTED FIRE ALARM STROBE (WHITE)	---	
⊙	WALL MOUNTED FIRE ALARM BREAKER / STROBE (WHITE)	---	
⊙	WEATHER PROOF FIRE ALARM BREAKER (PAINT TO MATCH BRICK)	---	
⊙	BYOKE DETECTOR - CEILING MOUNTED OR SURFACE MOUNTED	---	
⊙	BYOKE DETECTOR - DUCT MOUNTED	---	
⊙	HEAT DETECTOR	---	
⊙	SPRINKLER FLOW SWITCH	---	
⊙	SPRINKLER TAMPER SWITCH	---	
⊙	DOOR HOLD DEVICE (WALL MOUNTED)	---	
⊙	DOOR HOLD DEVICE (FLOOR MOUNTED)	---	
⊙	PRESSURE SWITCH	---	
⊙	CONDUIT CONCEALED IN WALLS ABOVE CEILING, OR EXPOSED WHERE NO CEILING	---	
⊙	CONDUIT CONCEALED IN SLAB, IN GROUND, OR UNDERFLOOR	---	
⊙	WEATHER PROOF	---	
⊙	G GROUND FAULT INTERRUPT	---	
UNO	UNLESS NOTED OTHERWISE	---	
NF	NON RUSED	---	
SN	SOLID NEUTRAL	---	

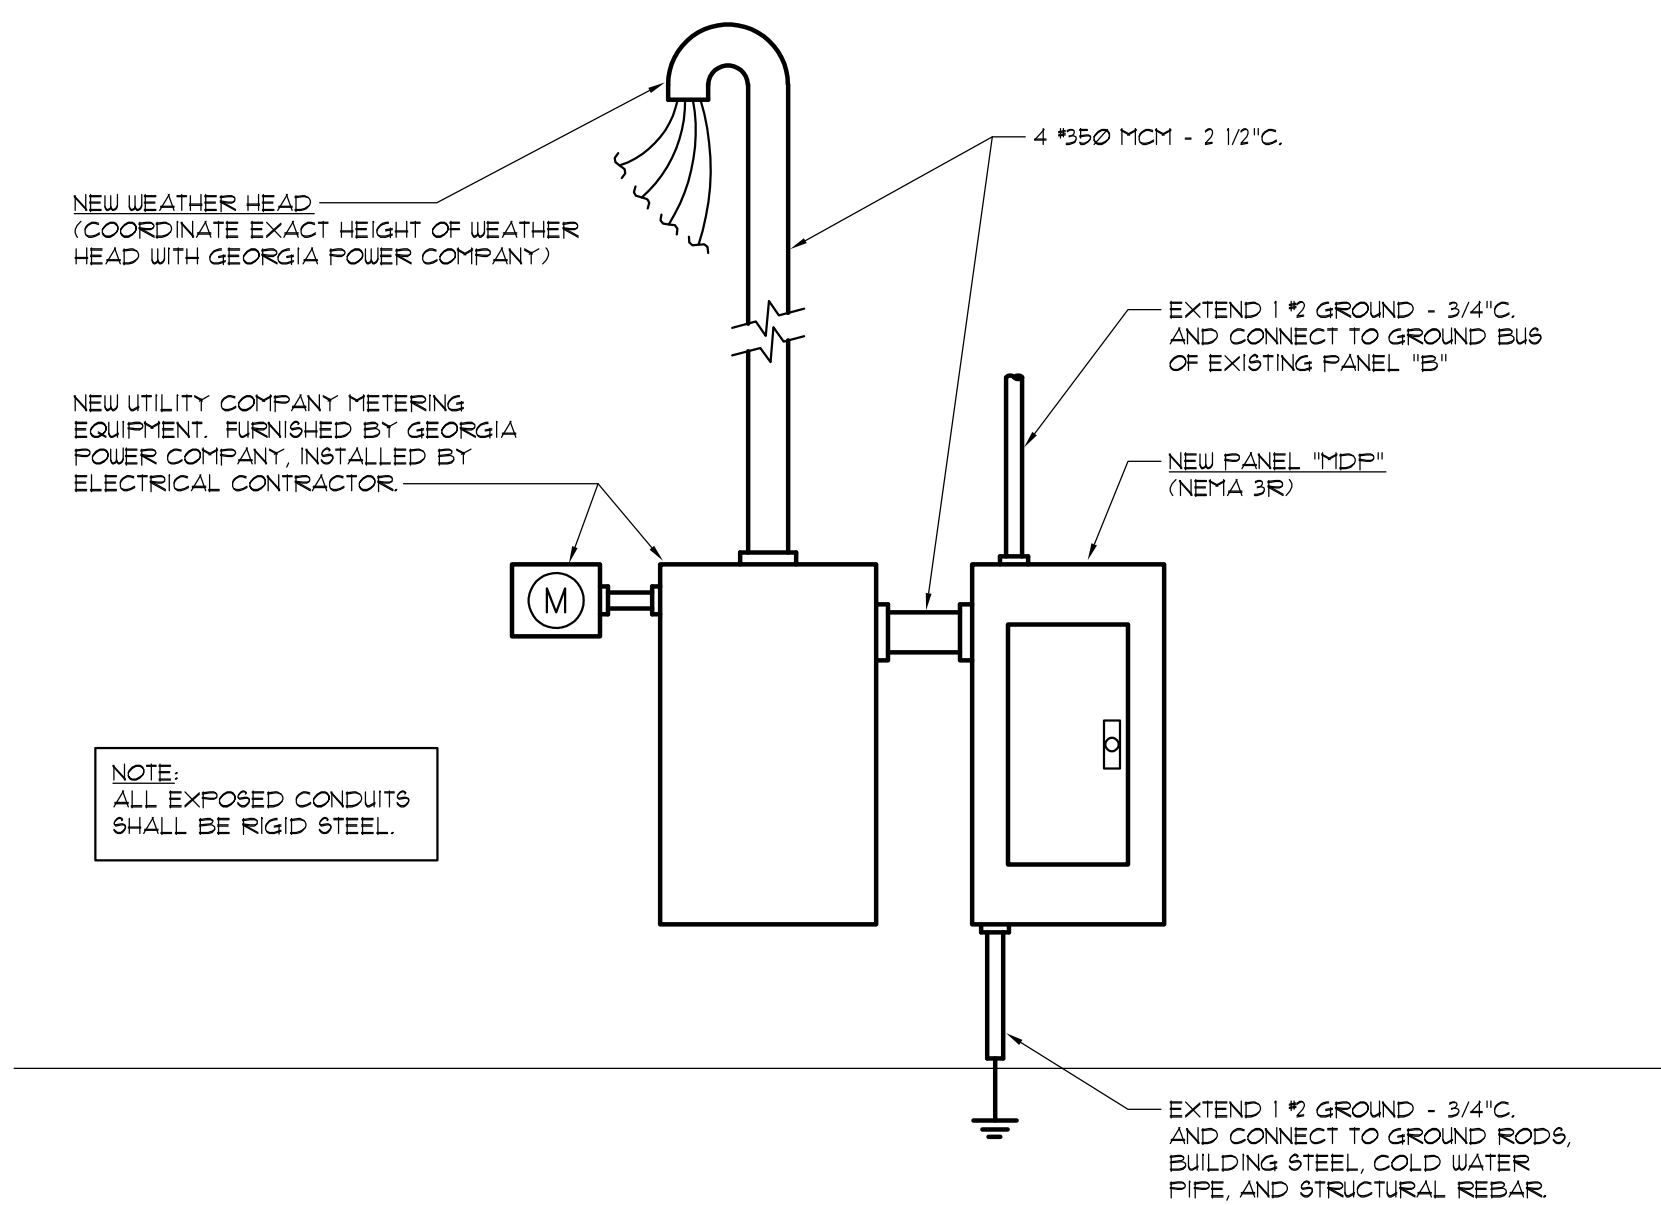


1
E0.1

RISER DIAGRAM

NOT TO SCALE

NOT TO SCALE

Alpharetta, Georgia 30005 | (678) 585-4508

 

IM

2022-106

[illegible]

(FACILITY CODE: 671-0178)

HARALSON COUNTY SCHOOLS

**SYMBOL LEGEND,
GENERAL NOTES,
PANELBOARD
SCHEDULE, &
RISER DIAGRAM**

DATE	01/04/2023
------	------------

PROJECT NO.	22131
-------------	-------

E0.1



ELECTRICAL NOTES

1. REMOVE EXISTING WIRING AND DISCONNECT SERVING EXISTING TO BE REMOVED GAS UNIT HEATER. LABEL BREAKER AS A "SPARE" AND LEAVE IN "OFF" POSITION.
2. REMOVE EXISTING WIRING AND DISCONNECT SERVING EXISTING TO BE REMOVED DIE WALL EXHAUST FAN. LABEL BREAKER AS A "SPARE" AND LEAVE IN "OFF" POSITION.
3. INSTALL NEW BREAKER, SIZE AS SCHEDULED IN EXISTING PANEL, "B". NEW BREAKER SHALL BE SAME RATING AS EXISTING PANEL. CONTRACTOR SHALL VERIFY EXISTING PANEL, PROPERLY UPDATE PANEL DIRECTORY. CONTRACTOR IS ALLOWED TO REUSE EXISTING CONDUIT IF PRESENT INSTALLATION MEETS CODE. NEW WIRING, DISCONNECT, AND DISCONNECT SHALL BE INSTALLED PER CODE.
4. NEW DUCT MOUNTED SMOKE DETECTOR SHALL BE FURNISHED BY DIVISION 26. INSTALLED BY DIVISION 23, AND WIRED BY DIVISION 26. NEW DUCT DETECTOR SHALL BE OF THE SAME MANUFACTURER AS EXISTING FIRE ALARM CONTROL PANEL. THIS DETECTOR IS TO BE USED FOR PROTECTION OF THE NEW DUCT MOUNTED SMOKE DETECTOR WITH EXISTING FIRE ALARM CONTROL PANEL, INCLUDING PROGRAMMING.
5. NEW CARBON MONOXIDE DETECTOR SHALL BE OF THE SAME MANUFACTURER AS EXISTING FIRE ALARM CONTROL PANEL. THIS DETECTOR IS RESPONSIBLE FOR PROPER PROTECTION OF NEW CARBON MONOXIDE DETECTOR WITH EXISTING FIRE ALARM CONTROL PANEL, INCLUDING PROGRAMMING.

